


21-36X1
CHIMNEY

21-32E1A1
COMBUSTION FUMES EXCHANGER

21-36K1A1
COMBUSTION FUMES FAN

21-32K3A1
COMBUSTION AIR FAN

21-32X3A1/B1
Reaction burner

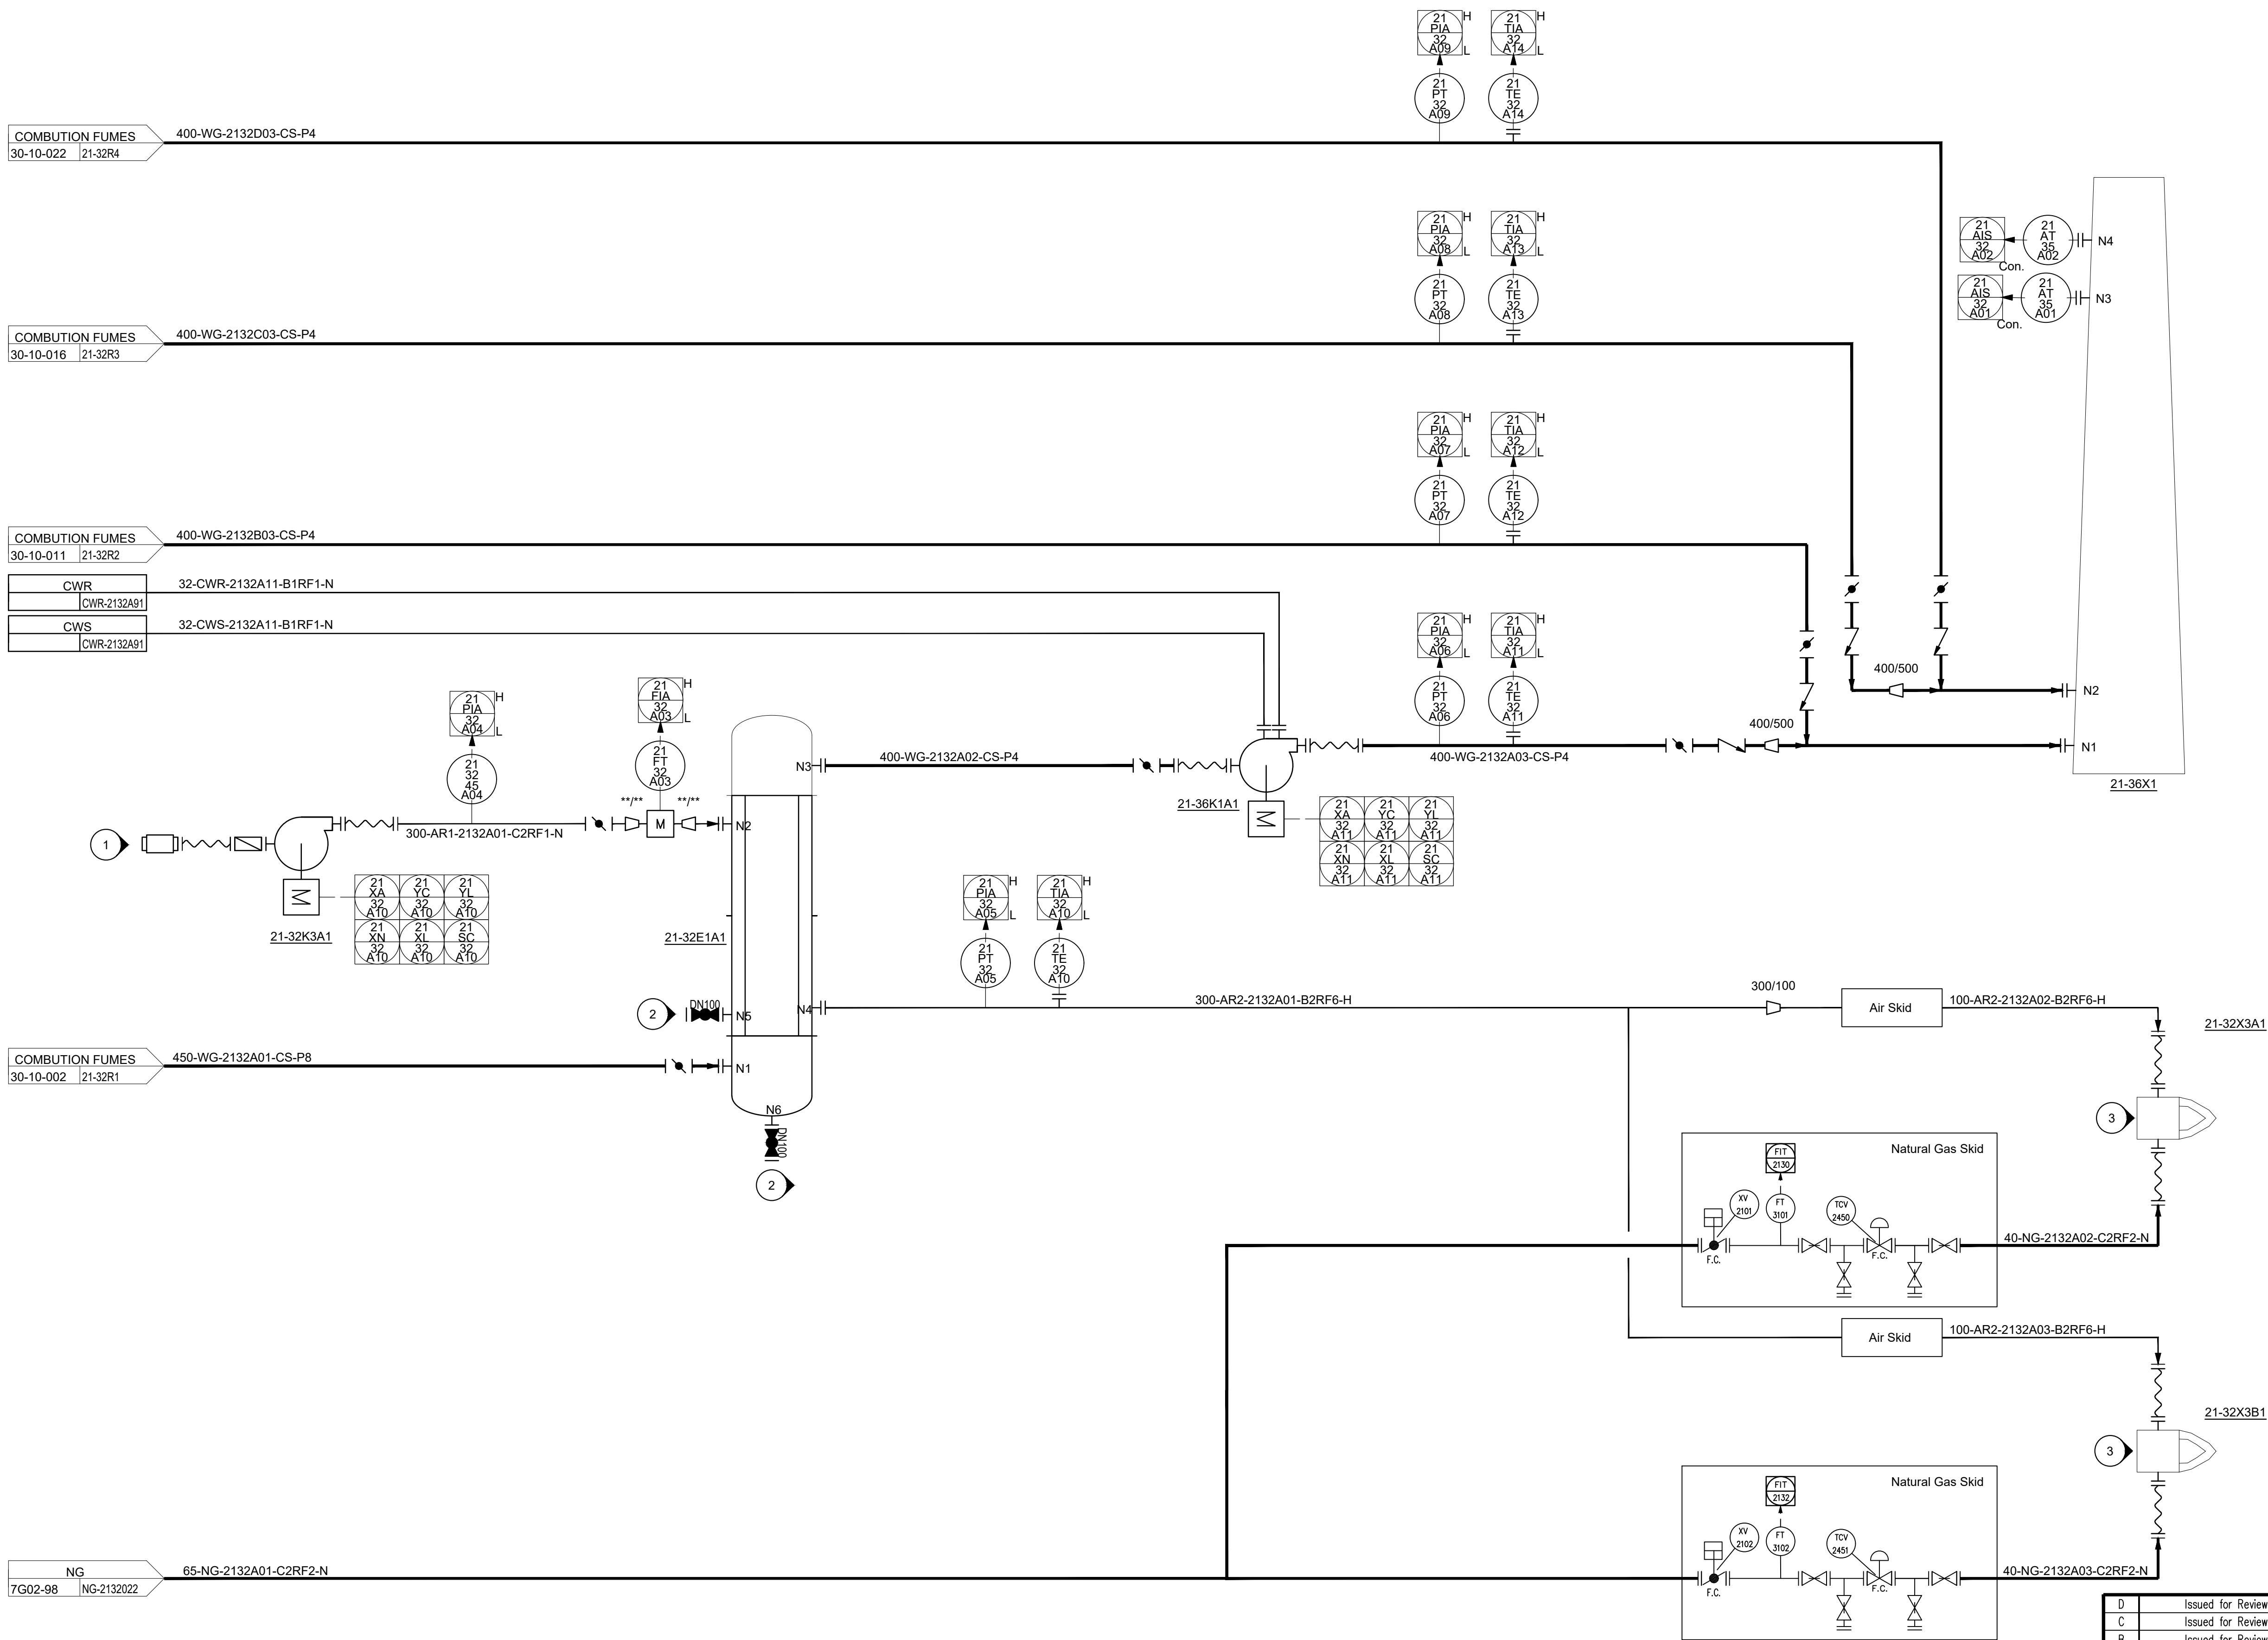

- NOTES
1.

The air blower inlet needs to be equipped with a muffler, filter, and hose, which are designed and supplied by the vendor.
2.

For back blowing.
3.

The burner belongs to the auxiliary facilities of the reactor, and is designed and supplied by the reactor vendor.
5.

Схема трубной обвязки и КИПиА предусматривается на одну группу реакторов, который состоит из 4-х реакторов.

23.106.02-7G21-30-TX					
Строительство завода по производству минеральных удобрений в г.Жанатос					
Изм.	Кол.уч.	Лист	№ док.	Подпись	Дата
Нач. отдела	Юрченко	11.24	6-511		
Проверил	Юрченко	11.24	6-511		
Разработал	Озгиднаков	11.24			
Н.контр.	Малева	11.24			
Установка по производству сульфата калия			Страница	Лист	Листов
Схема трубной обвязки и КИПиА для установки производства сульфата калия 1-4-я реакционная система и система абсорбции			П	10	
			KONT		

D	Issued for Review	2024-04-11	Xu Yanda		Zhang Jinzhi	Xu Hang	
C	Issued for Review	2024-02-06	Xu Yanda		Zhang Jinzhi	Xu Hang	
B	Issued for Review	2023-11-11	Xu Yanda		Zhang Jinzhi	Xu Hang	
A	Issued for Review	2023-03-22	Xu Yanda		Zhang Jinzhi	Xu Hang	
Rev.	PURPOSE OF ISSUE	DATE	DESIGN	DRAW	CHECK	REVIEW	APPROVAL
CONTRACTOR Drawing Number			Change No.				0
COMPANY:			CONTRACTOR:				
EUROCHEM			中国天辰 CHINA TIANCHEN				
P&ID for SOP Plant 1st~4th Reaction System and Absorption System			PROJECT		Chemical Complex for Phosphates Processing Project		
			UNIT		SOP Plant		
			PHASE		FEED		
SCALE		SHEET 1	TOT. 1	SIZE A1	DWG NO.	PRO-7G21-30-10-003	